


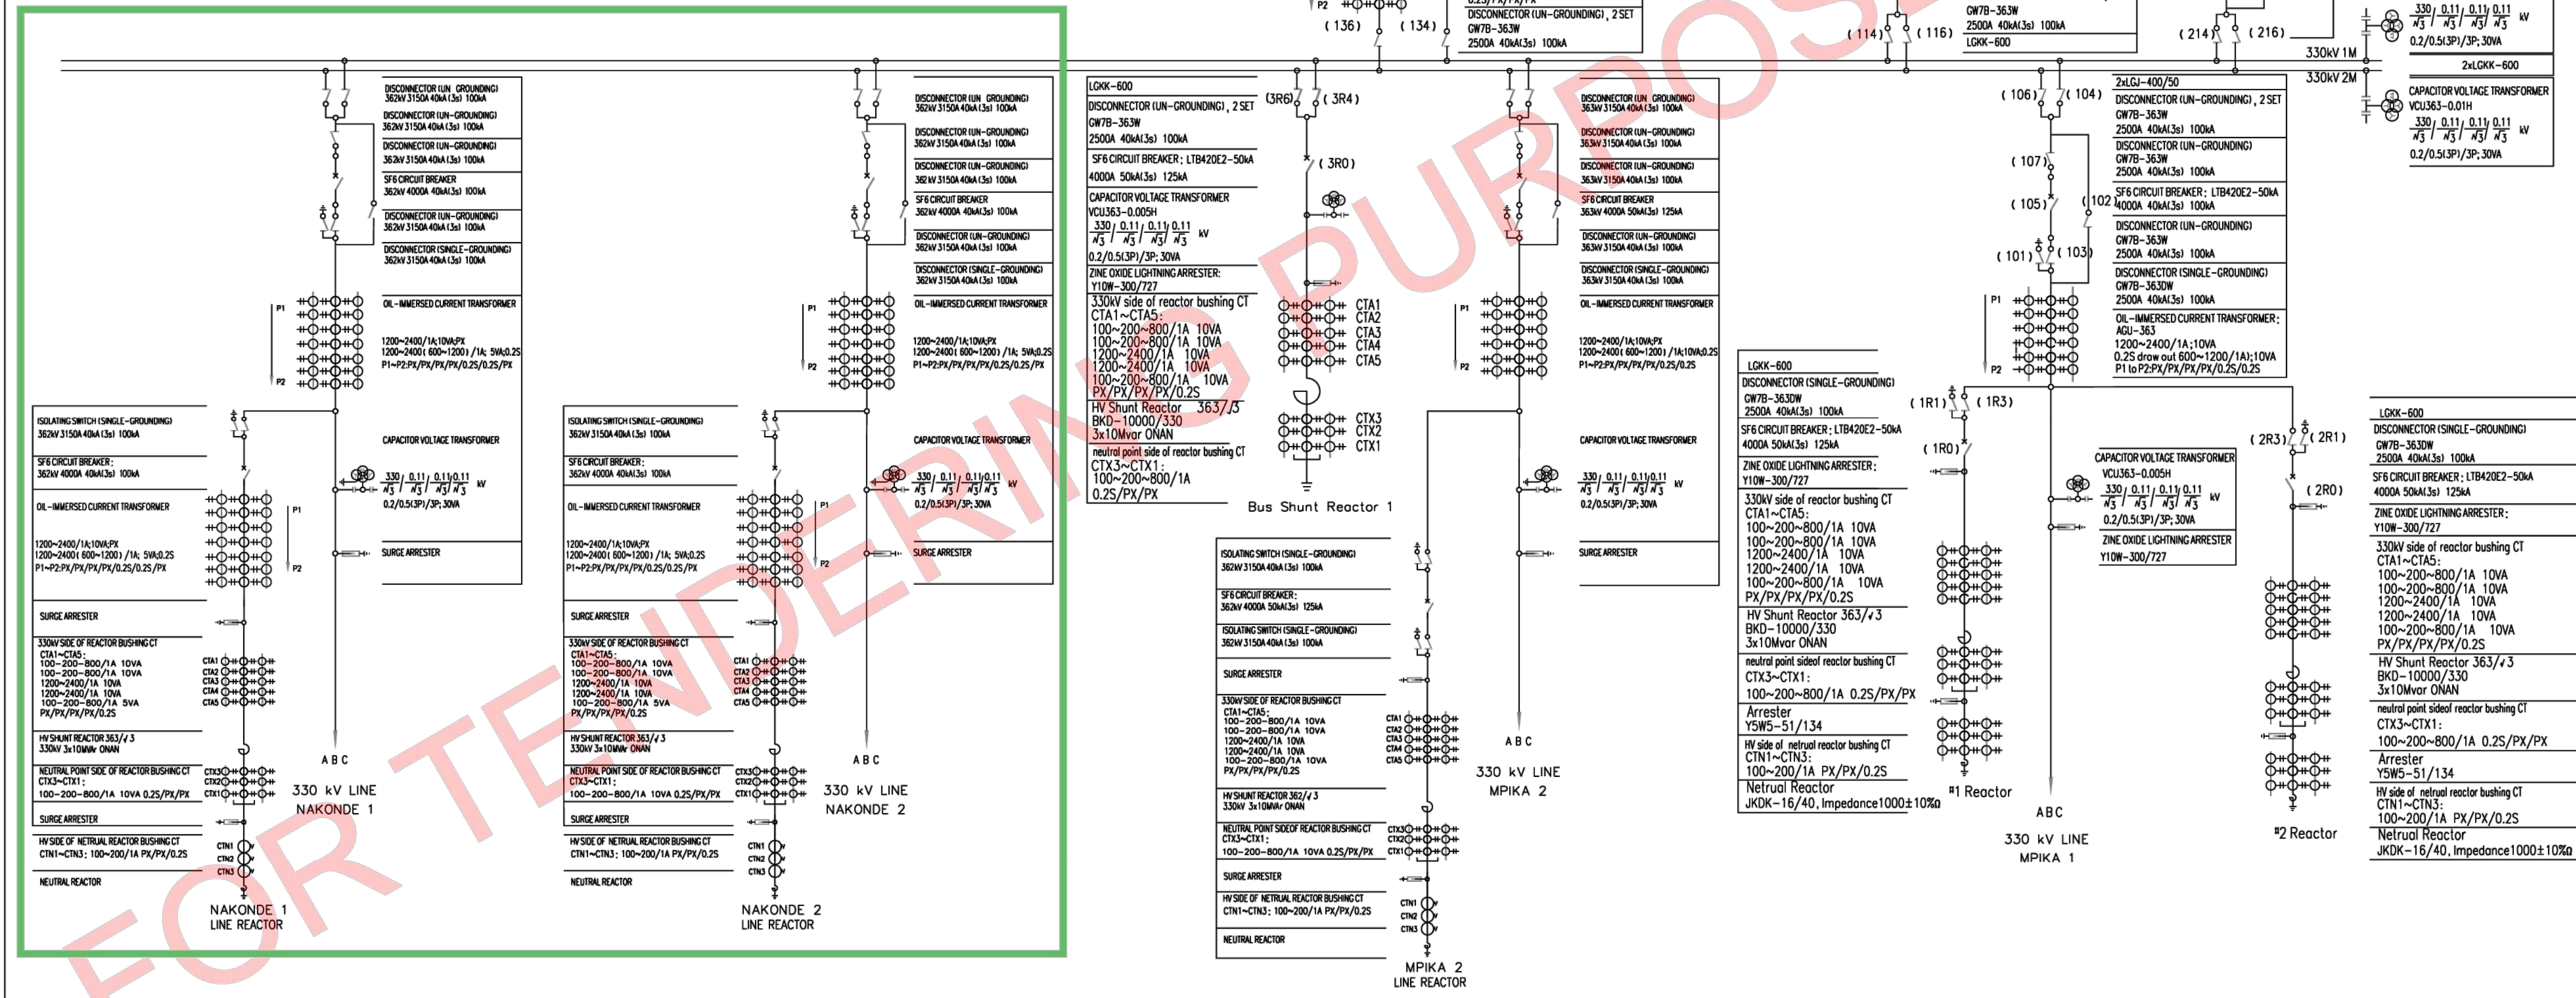

						CLIENT:		 WSP WSP Group Africa (Pty) Ltd Building C, Knightbridge, 33 Sloane Street, Bryanston, 2192 PO Box 98867 Sloane Park 2152 Tel: +27(0)11-361-1402 Fax: +27(0)11-361-1301 l&b-bry@wspgroup.co.za				PROJECT:				SCALE : NTS				CHECKED: MH		APPROVED: DB																											
						SAPP (ZESCO)						SAPP - ZTIP Phase 2				DESIGN: AG		DRAWN: AG		DATE: 02/07/2020																													
																PROJECT No: 48100008		DRAWING No: 48100008-KASAMA-SLD 01		REV: 1																													
DRAWING STATUS: PRELIMINARY						If drawing status = construction, a signed copy of this drawing (either in hardcopy or electronic format) is available at the office of origin and at the office of issue.						TITLE: KASAMA SUBSTATION SLD				© COPYRIGHT RESERVED The content of this document is privileged and confidential and may not be disclosed or reproduced without the express authorization of the author, being "WSP GROUP/AFRICA (PTY) LTD"				 Counting engines built																													
<table><tr><td></td><td></td><td></td><td></td><td></td><td></td></tr><tr><td></td><td></td><td></td><td></td><td></td><td></td></tr><tr><td>1</td><td>14/07/2020</td><td>AG</td><td>REMOVE BUS REACTOR 2 AS PER ZESCO</td><td>MH</td><td>AG</td></tr><tr><td>0</td><td>18/06/2020</td><td>AG</td><td>FIRST DRAFT - FOR COMMENT</td><td>MH</td><td>AG</td></tr><tr><td>REV</td><td>DATE</td><td>BY</td><td>DESCRIPTION</td><td>CHK</td><td>APD</td></tr></table>																		1	14/07/2020	AG	REMOVE BUS REACTOR 2 AS PER ZESCO	MH	AG	0	18/06/2020	AG	FIRST DRAFT - FOR COMMENT	MH	AG	REV	DATE	BY	DESCRIPTION	CHK	APD														
1	14/07/2020	AG	REMOVE BUS REACTOR 2 AS PER ZESCO	MH	AG																																												
0	18/06/2020	AG	FIRST DRAFT - FOR COMMENT	MH	AG																																												
REV	DATE	BY	DESCRIPTION	CHK	APD																																												



Project Name
Proposed Nakonde Stepdown
330/(132)66/11kV Substation

Drawing Name				
Kasama Substation Single Line Diagram				
Document Status	Sheet Number	Scale	Paper Size	Issue Date
EXT	E101	NTS	A1	Jun 2026
Drawing Number				Revision Number
PP-ZTIP-P04-ODSS-E101				01

THIS DRAWING IS THE PROPERTY OF ZESCO LIMITED. COPYRIGHT AND RIGHT OF REPRODUCTION OF THIS DRAWING OR ANY PORTION THEREOF IS RESERVED BY THE MANAGING DIRECTOR.