



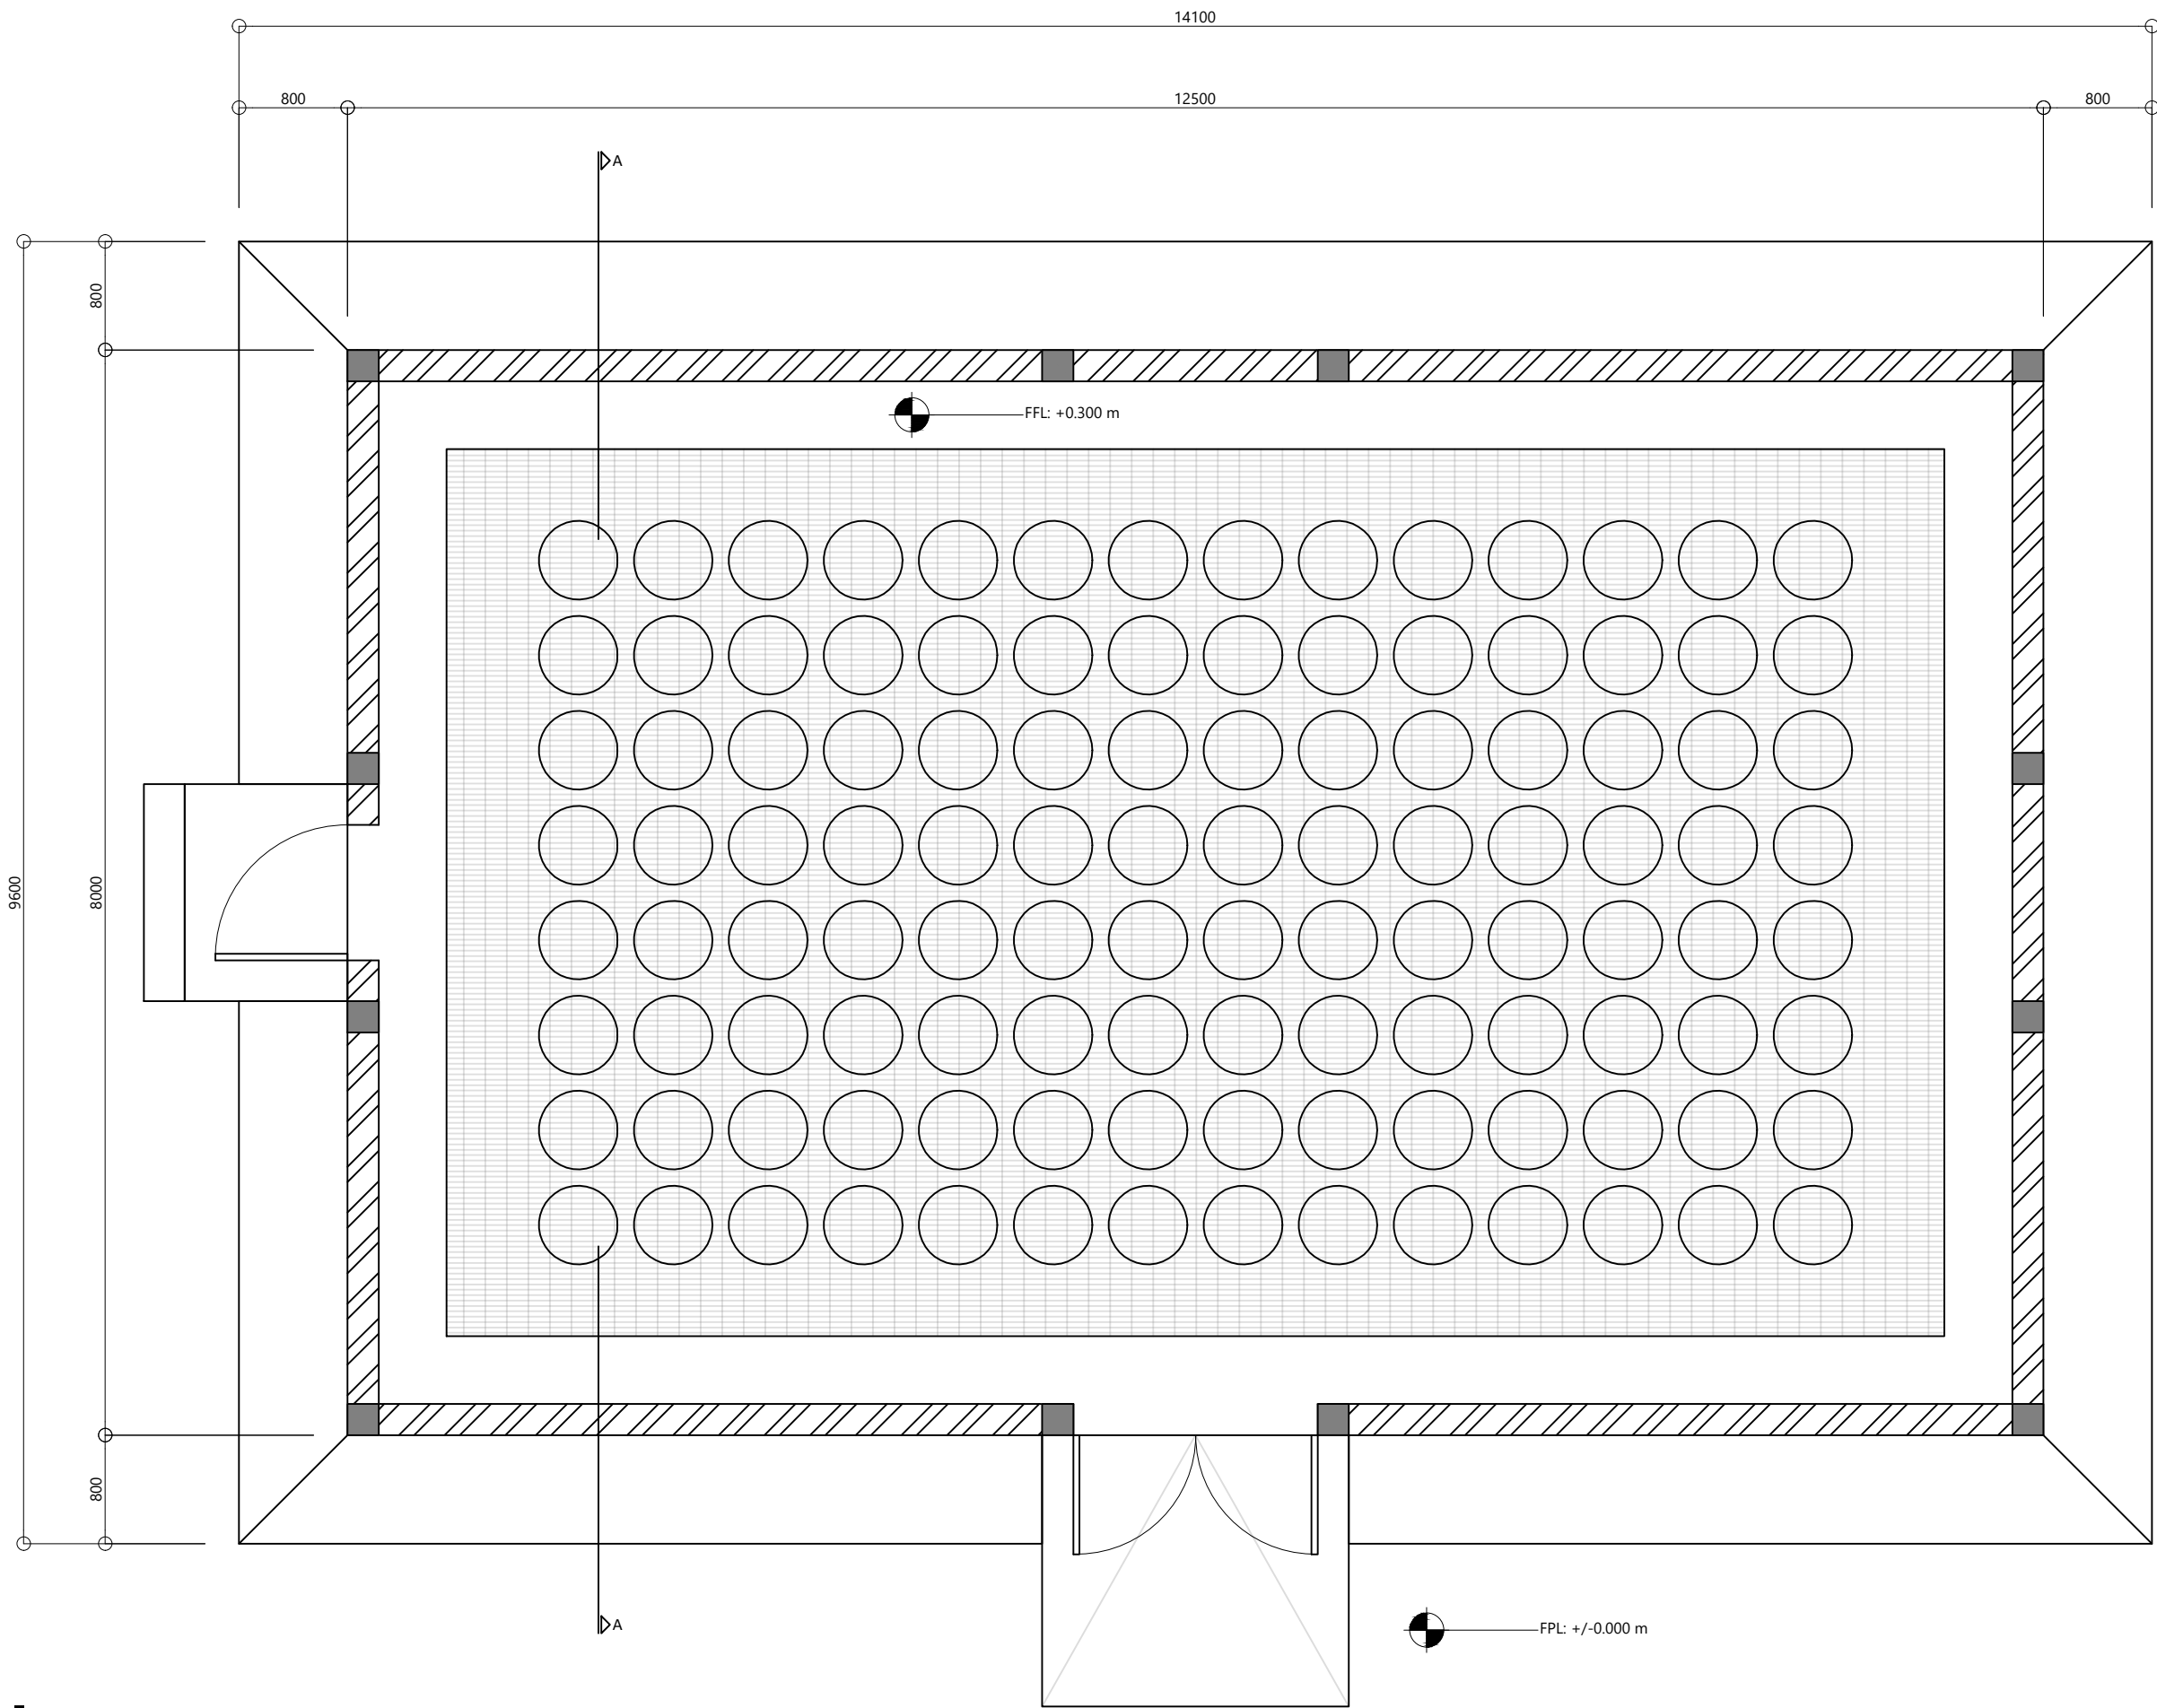

Plan

Scale 1:50

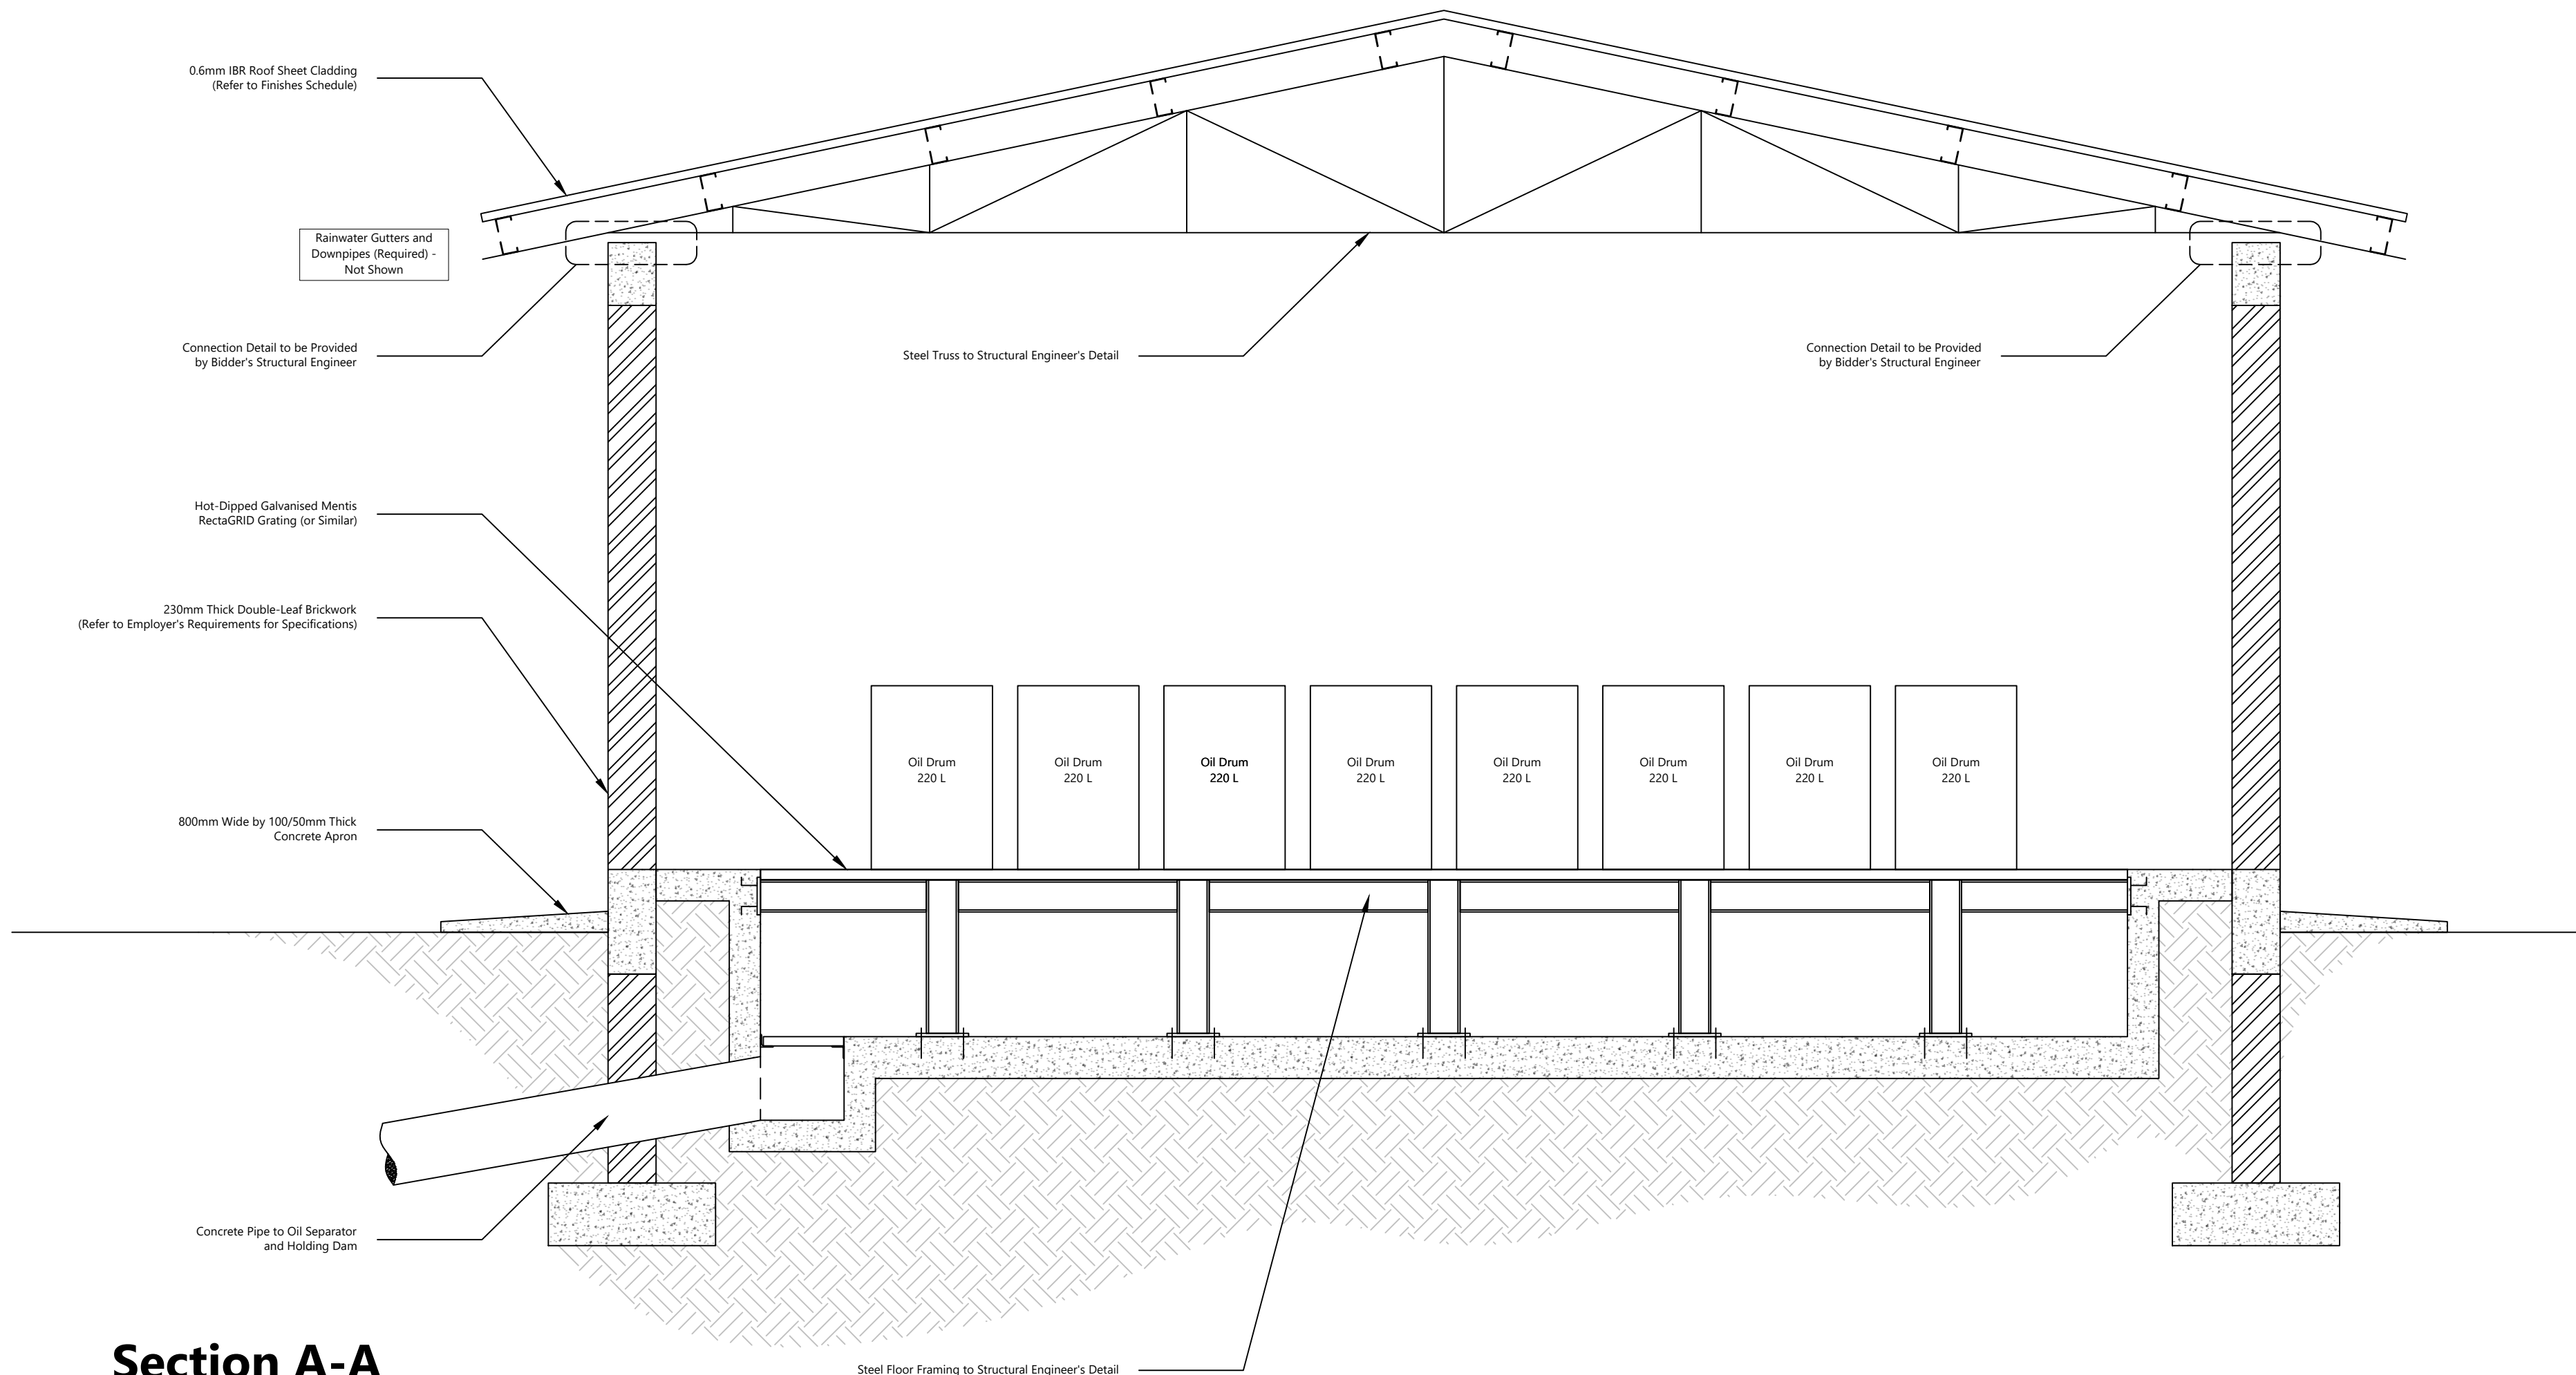


Section A-A

Scale 1:25



Front Elevation

Scale 1:50

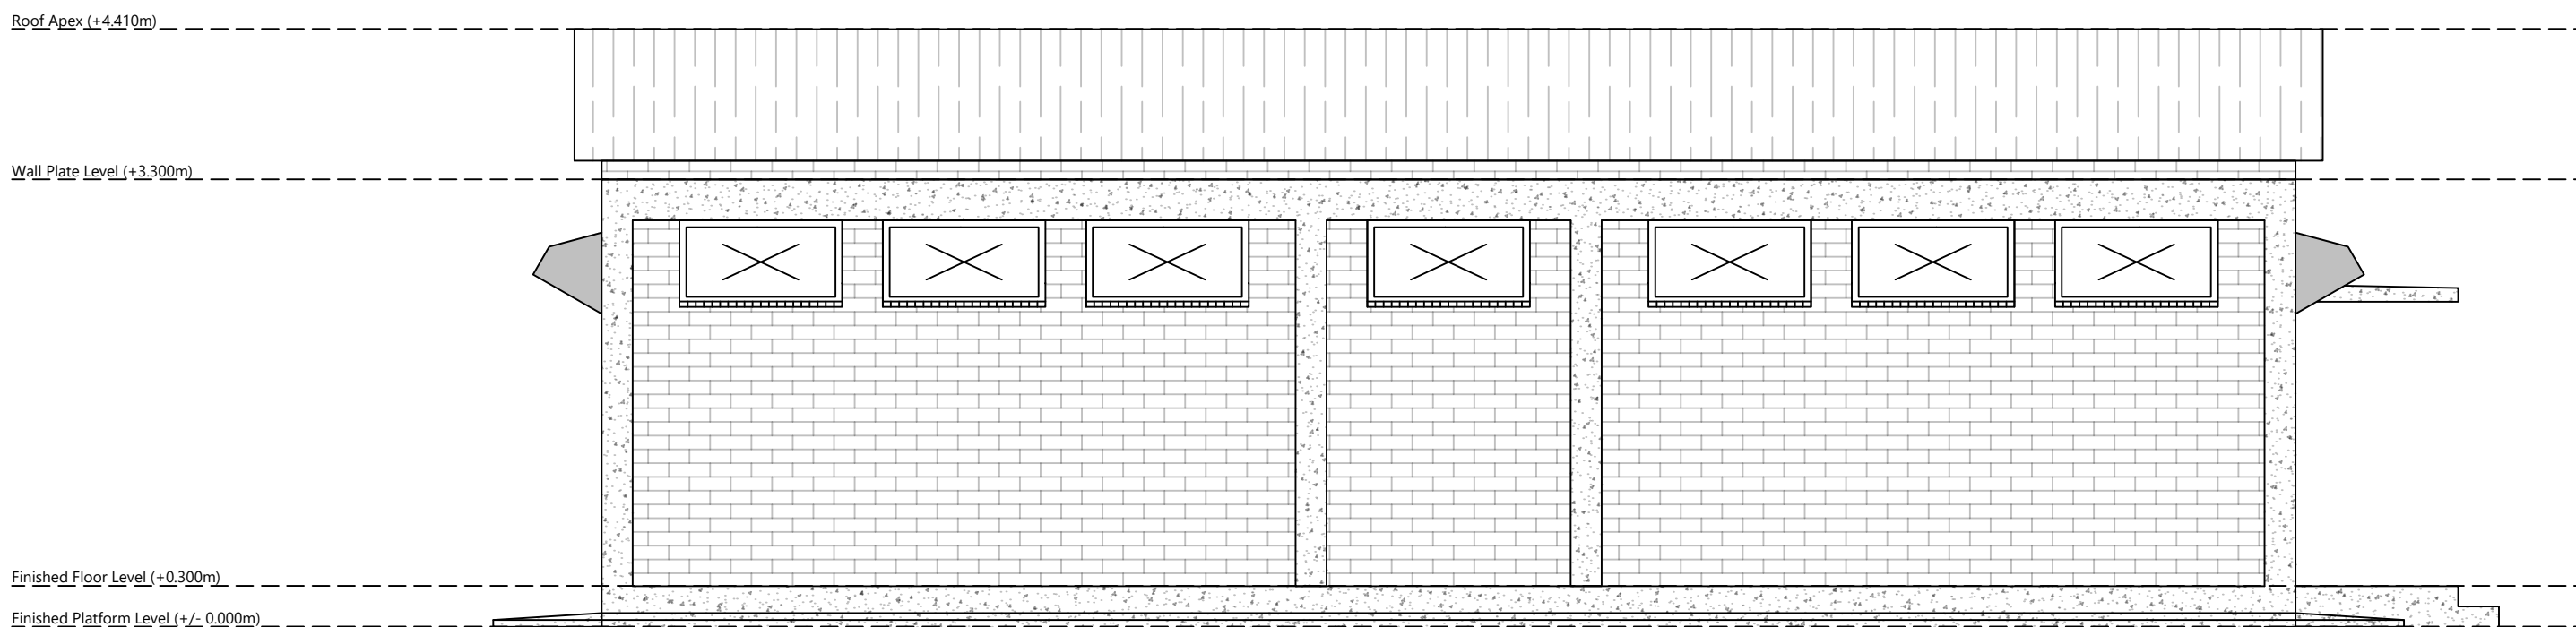


Rear Elevation

Scale 1:50



Left Elevation

Scale 1:50

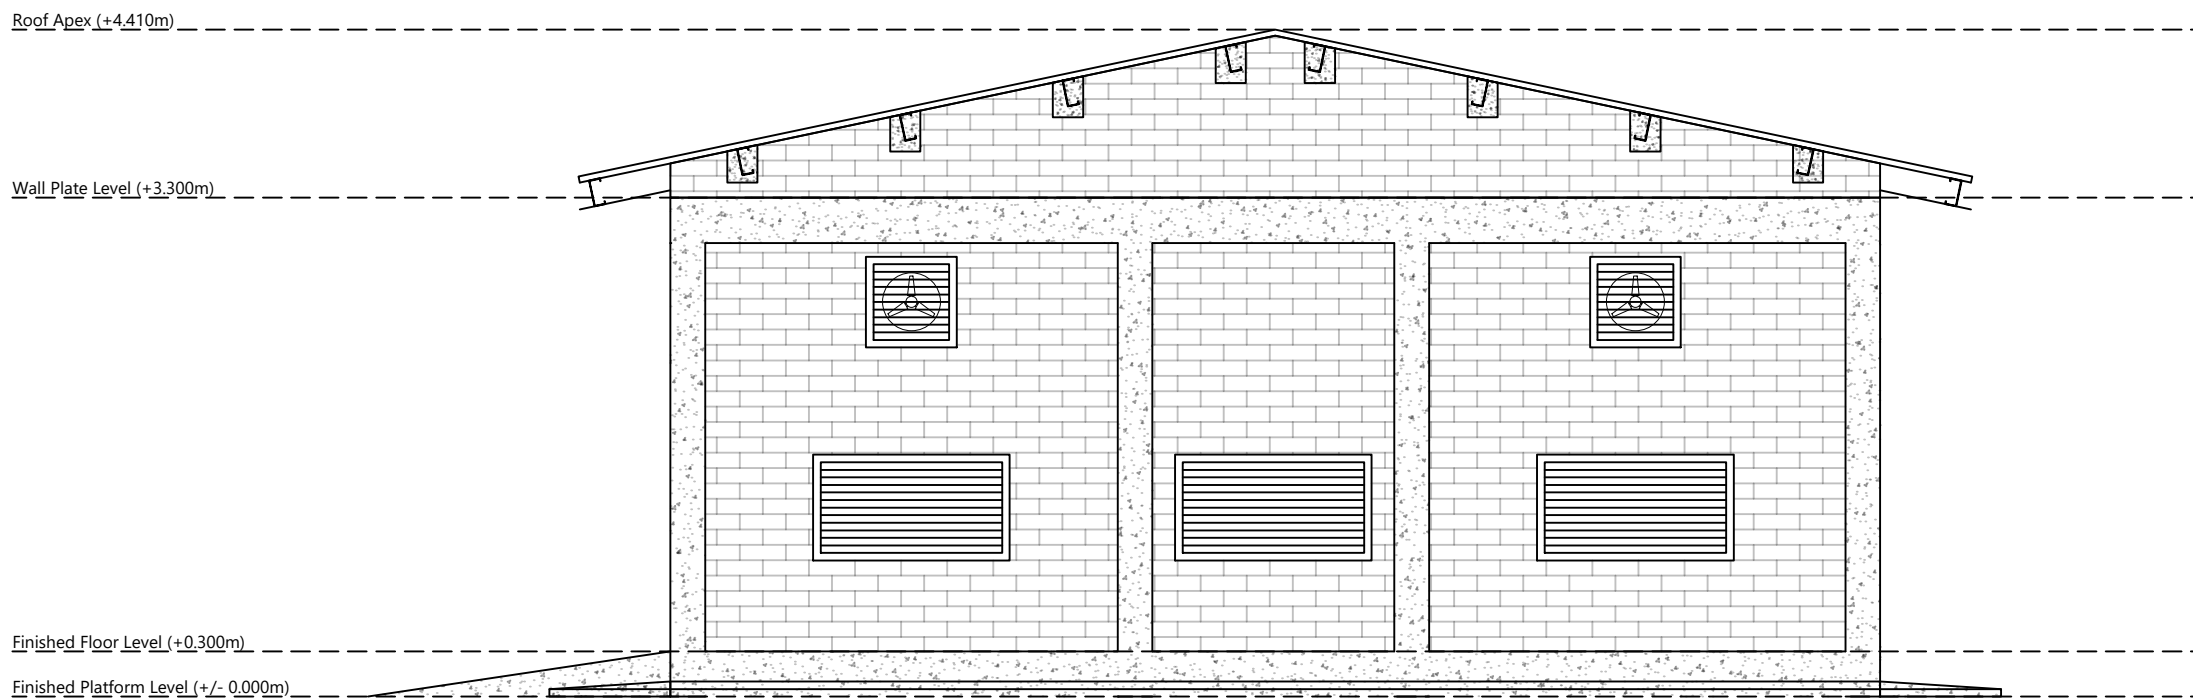

Right Elevation

Scale 1:50



Project Name
**Proposed Nakonde Stepdown
330/(132)66/11kV Substation**

Project Approval				Design Approval				Drawing Name			
Drawn By	Civil Eng. In-Charge	Electrical Eng. In-Charge	Project Manager	Designed By	Checked By	Approved By	Document Status	Sheet Number	Scale	Paper Size	Issue Date
C. Chundu	C. Chundu	Z. Sakala	H. Mulapani	C. Chundu	M. N. Siluyele	J. Nyondo	EXT	C106	As Shown	A1	Jun 2026
Jun 2026	Jun 2026	Jun 2026	Jun 2026								
Revisions				Drawing Number				Revision Number			
00	For Tendering Purposes Only	30/06/2026	C.C.	PP-ZTIP-P04-ODSS-C106				00			
Rev.	Description	Date	By								